



Revisions		
Date	Description of Change	Initials
07/07/17	Original Release	PRG

SINGLE LINE DIAGRAM

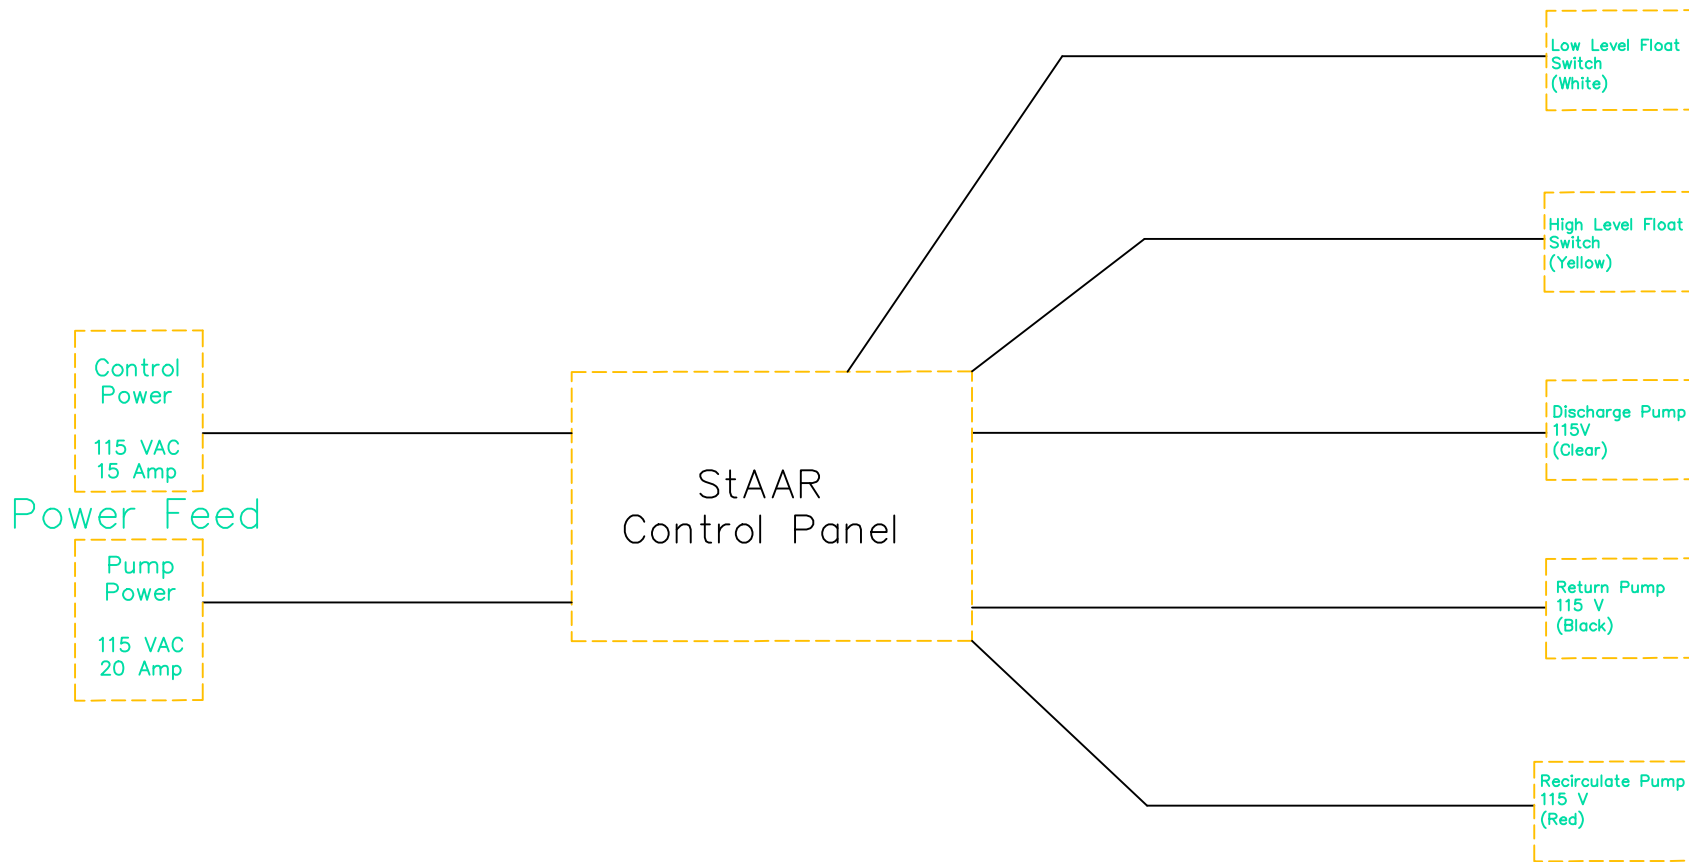

NOTES:
 1) All Wiring to the tank should be minimum #14 AWG THHN or TFFN unless otherwise noted.

DES.BY: PRG	DR.BY: PRG	CK.BY: PRG
STAAR 0.5_0.75_1.0 115 VOLT		
DATE: 07-07-2017	DWG.: UR4005507502	
SCALE: NTS	SHEET: 1	
 <small>a subsidiary of Bio-Microbics, Inc.</small>		